





Brentwood Manor

3 BEDROOM 2 BATH

FIRST FLOOR AREA SCHEDULE	
GROUND FLOOR	44.11m ²
SINGLE GARAGE	20.38m ²
GF TOTAL	64.49m²
FIRST FLOOR	60.69m ²
UNIT TOTAL	125.18m²
SINGLE CARPORT	12.50m ²
TOTAL	137.68m²

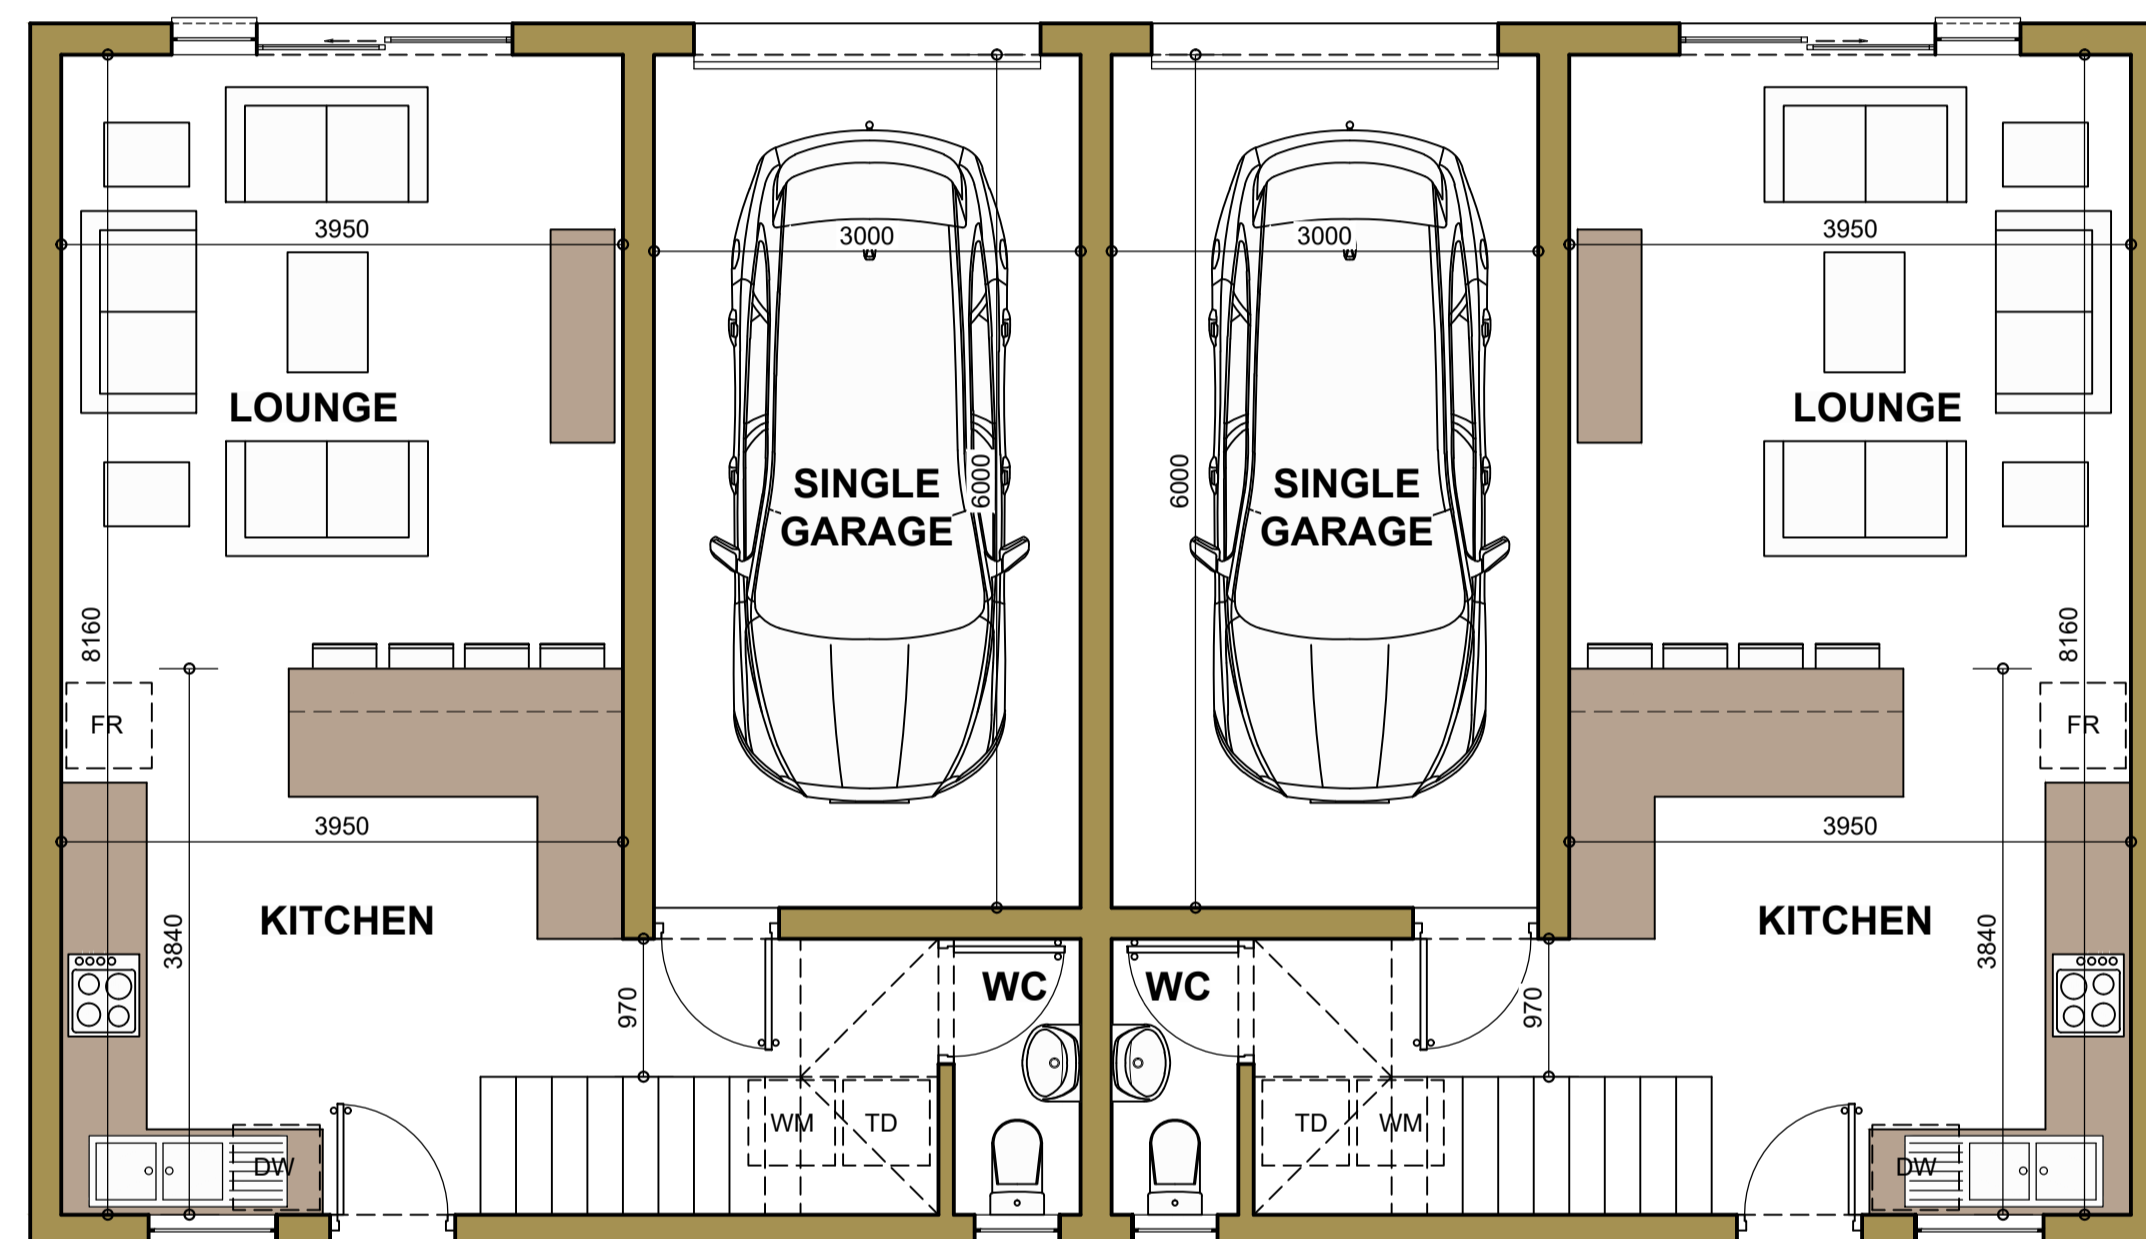


GROUND STOREY PLAN
SCALE 1:50

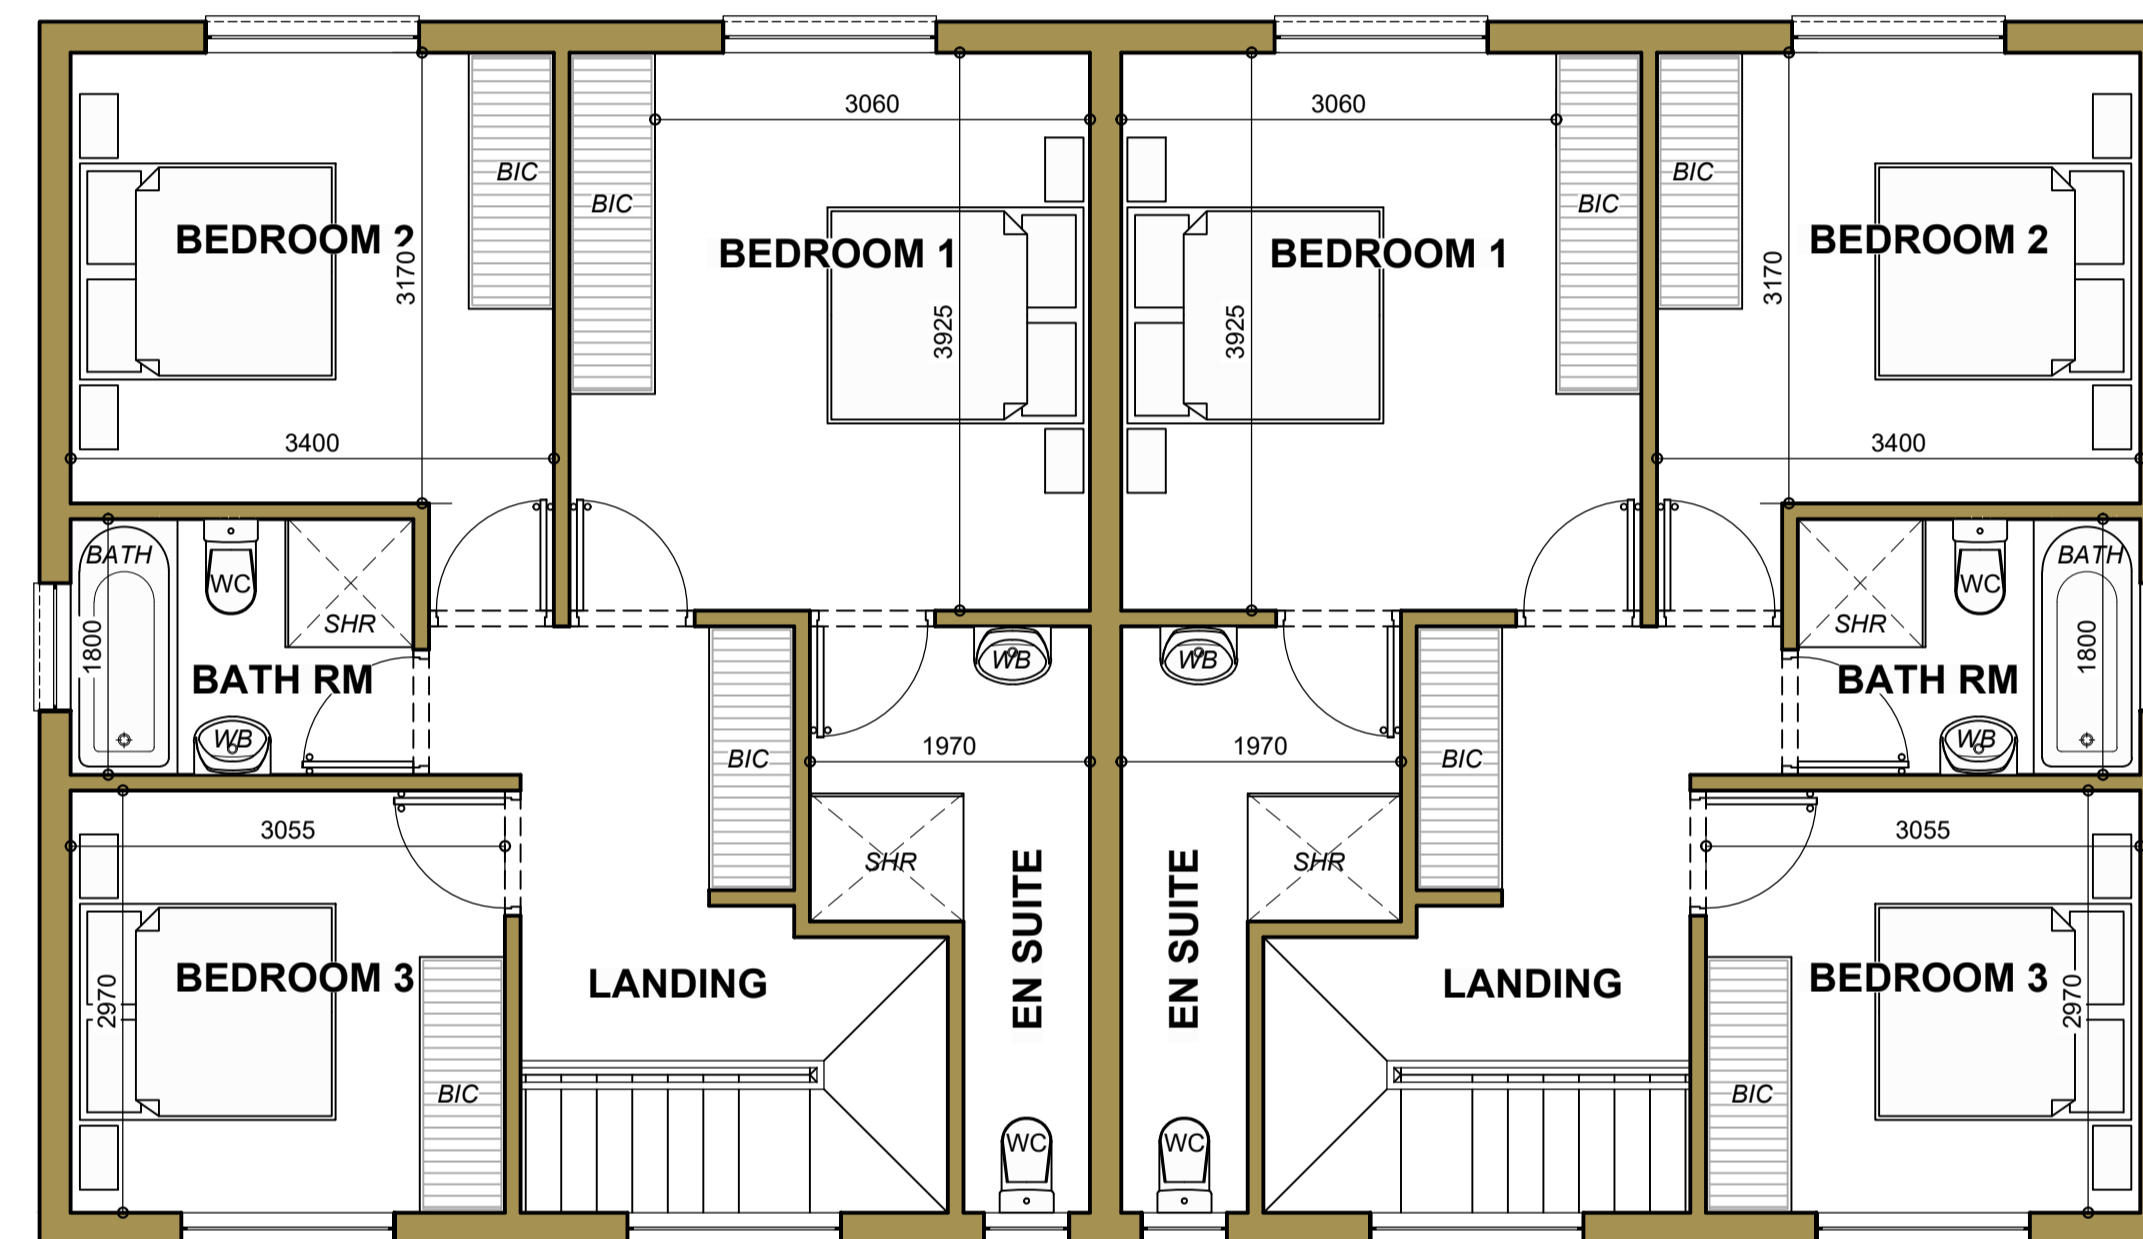

FIRST STOREY PLAN
SCALE 1:50

TYPE B

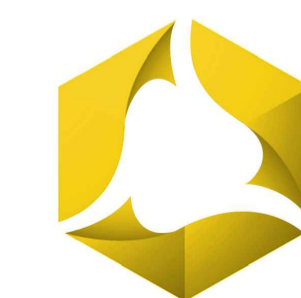

SSI
Group